

ALL INFORMATION APPEARING HEREIN SHALL NOT BE REPRODUCED, COPIED, OR OTHERWISE USED WITHOUT THE WRITTEN CONSENT OF THE COMBS DETHLEFS.


**CHRISTOPHER THOMAS KASTELIC**  
203517  
11.4.09

**SINK COMBS DETHLEFS**

A Professional Corporation 475 Lincoln Street, Suite 100, Denver, Colorado 80203 303.338.0333 FAX 303.328.0222



- GENERAL PLAN NOTES:**
- RE: SHEET A9.10 FOR INTERIOR AND EXTERIOR WALL TYPES.
  - REFER TO ROOM FINISH SCHEDULE AND INTERIOR ELEVATIONS FOR ALL FINISHES. IF ANY DISCREPANCY OCCURS VERIFY WITH ARCHITECT.
  - PROVIDE UNDER SLAB VAPOR BARRIER PER SOILS REPORT RECOMMENDATION @ THE GYMNASIUM, LIBRARY, OFFICES, CHILD SITTING, POOL PARTY ROOM, AND MULTI USE ROOMS.
  - CONTRACTOR TO COORDINATE LOCATION OF FIRE SPRINKLER LINES WITH DUCTS, LIGHTS, AND STRUCTURE. NOTIFY ARCHITECT IF ANY UNKNOWN CONDITION ARISES THAT CONFLICT WITH CEILING HEIGHT BEFORE PROCEEDING. ALL SPRINKLER LINES TO BE IN CEILINGS AND WALLS UNLESS SPECIFICALLY COORDINATED WITH ARCHITECT.
  - ARCHITECTURAL FLOOR ELEVATION 100'-0" = 4503 ON CIVIL DRAWINGS.
  - SLOPE ALL WET AREA FLOORS TO DRAINS @ 1/4" PER FOOT.
  - RE: A0.10 FOR CODE REVIEW & FIRE RATINGS.
  - ALL DIMENSIONS ARE NOMINAL AND TO FACE OF STUD UNLESS OTHERWISE NOTED.
  - REFER TO STRUCTURAL DRAWINGS FOR ALL BLOCK BACK-UP CONTROL JOINTS.
  - RE: ENLARGED PLANS FOR NOTES AND DIMENSIONS FOR LOCKER ROOMS AND RESTROOMS.
  - ALL WALL MOUNTED TV'S TO BE INSTALLED AT 8'-0" A.F.F. BOTTOM OF TV. PROVIDE WALL MOUNTING BRACKETS. TV'S N.I.C.
  - REFER TO PLUMBING DRAWINGS FOR ALL FLOOR DRAIN LOCATIONS.
  - REFER TO LANDSCAPE DRAWINGS FOR ALL PATIO AND EXTERIOR CONCRETE PATTERNS.
  - PROVIDE STAINLESS STEEL DRAIN COVERS AT ALL WET AREA FLOOR DRAINS, POOLS, LOCKER ROOMS, SHOWERS AND RESTROOMS.
  - CONTRACTOR TO REVIEW ALL SLOPES AND ADVISE IF CURRENT CONFIGURATION NEEDS TO BE MODIFIED.
  - COORDINATE T.V. LOCATIONS WITH FITNESS EQUIPMENT.
  - GAME LINES TO INCLUDE BASKETBALL, VOLLEY BALL, AND PICKLEBALL.

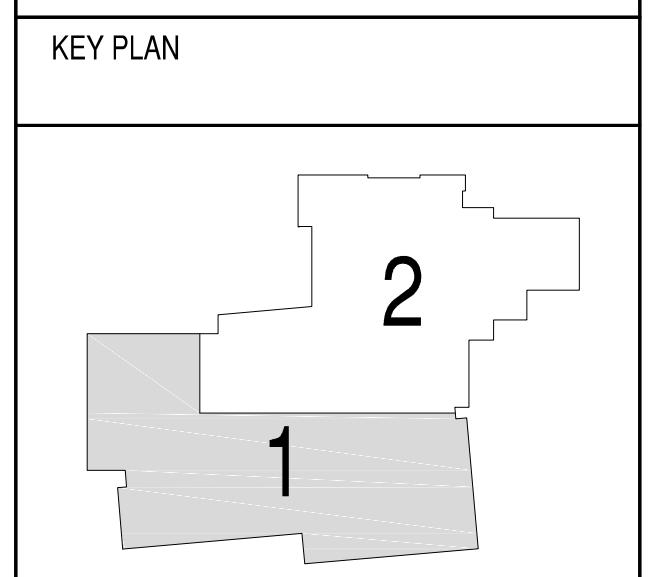

Issues/Revisions:	Date:
SCHEMATIC DESIGN	04-13-09
DESIGN DEVELOPMENT	07-10-09
90% CD'S	09-07-09
CONSTRUCTION DOCUMENTS	09-22-09
FINAL CD'S	11-04-09

**FRUITA COLORADO LIBRARY CENTER & MESA COUNTY LIBRARIES/ FRUITA BRANCH**

FRUITA COLORADO

SCD Project No.: 0901

**SECOND LEVEL FLOOR PLAN AREA 1**

Drawn by:  
Checked by:

**A2.21**

**1 SECOND LEVEL FLOOR PLAN- AREA 1**  
SCALE: 1/8" = 1'-0"  
NORTH  
0' 4' 8' 16'